



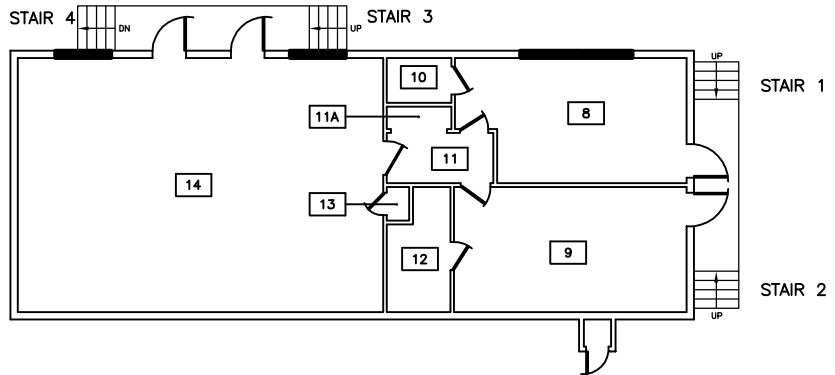

CITY OF GLENDALE
 PUBLIC WORKS CORPORATION YARD
 FIRE DEPARTMENT
 CLASSROOM BUILDING AND
 FIRE TRAINING (MODULAR BUILDING)
 FIRST FLOOR PLAN

Scale: 1/16"=1'-0"

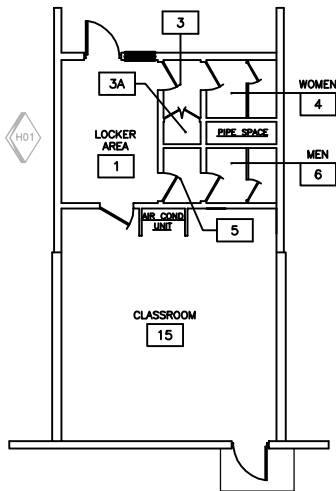

City of Glendale Public Works, Facilities Services	PROJECT: City of Glendale Facilities Update 1994 ADA Survey	REGISTRATION:	DRAWING NO.:
	SUBJECT:	SCALE:	A/E PROJECT NO.:
		DRAWN BY:	DATE:
		SHEET REF.:	